


1 FIRST FLOOR HVAC PLAN  
 M.02 SCALE: 1/4" = 1' N

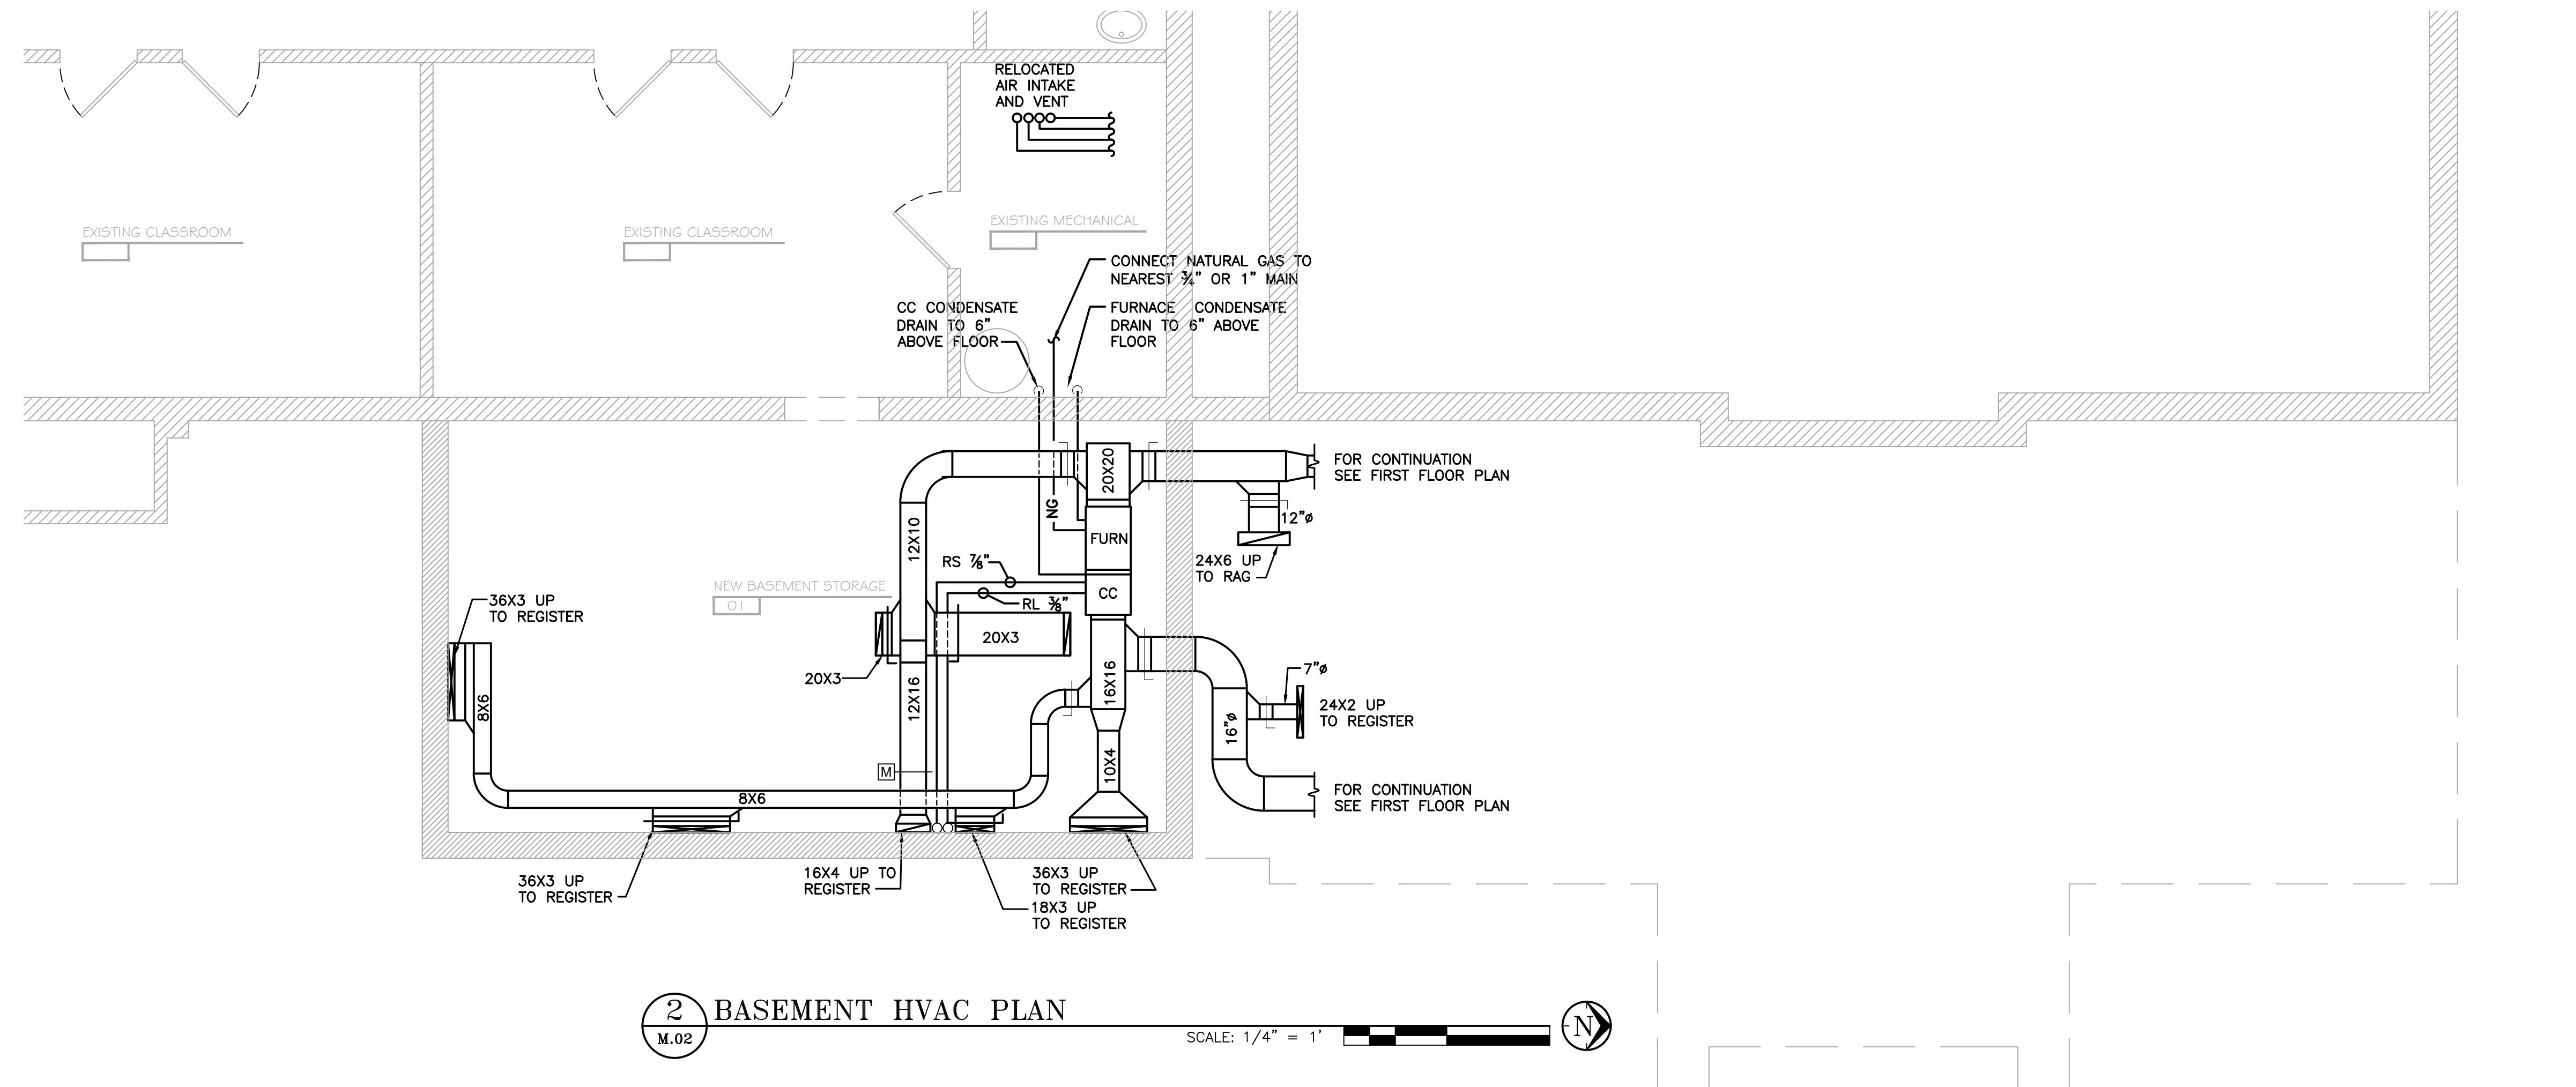

2 BASEMENT HVAC PLAN  
 M.02 SCALE: 1/4" = 1' N

Verify all existing site conditions  
 REVISIONS:

SHEET INDEX:  
 HVAC PLAN

Copyright © 2017 Isaac House, Inc.	
DRAWN	APPRVD
PG	DP
MAY 15, 2017	