


DXF file created by LitePro 2.030 on 4/14/2017 4:07:16 PM

| CALCULATION SUMMARY | | | | | | | | | | |
|---------------------|---------------------|----------------|-------|------|-------|------|------|------|---------|---------|
| AREA NAME | DIMENSIONS | GRID / TYPE | # PTS | SPAC | GROUP | AVE | MAX | MIN | MAX/MIN | AVE/MIN |
| narthex ltr | 87.90x51.20x14.50ft | New Grid / H-H | 283 | 2.00 | (<+) | 2.27 | 6.48 | 0.18 | 36.87 | 12.89 |

| Mt Olive Church LUMINAIRE SCHEDULE | | | | | | |
|------------------------------------|--------|--|------|--------|------------------|---------|
| TYP | SYMBOL | DESCRIPTION | LAMP | LUMENS | MOUNTING/BALLAST | LLF QTY |
| D1E | • | ATLANTIC LIGHT LED7-DLM1-35K-7LED10-CL | (1) | 600 | | 0.81 2 |
| D2E | • | ATLANTIC LIGHT LED7-DLM20-35K-7LED10-CL | (1) | 600 | | 0.81 6 |

| AREA SUMMARY SCHEDULE | | | | | |
|-----------------------|-----|---------------------|--------------------|---------------|-----|
| AREA NAME | L/O | DIMENSIONS | LUMS / (ASMS) | WATTS / SQ FT | QTY |
| narthex ltr | IN | 87.90x51.20x14.50ft | D1E (2) D2E (6) | 0.04 | 1 |

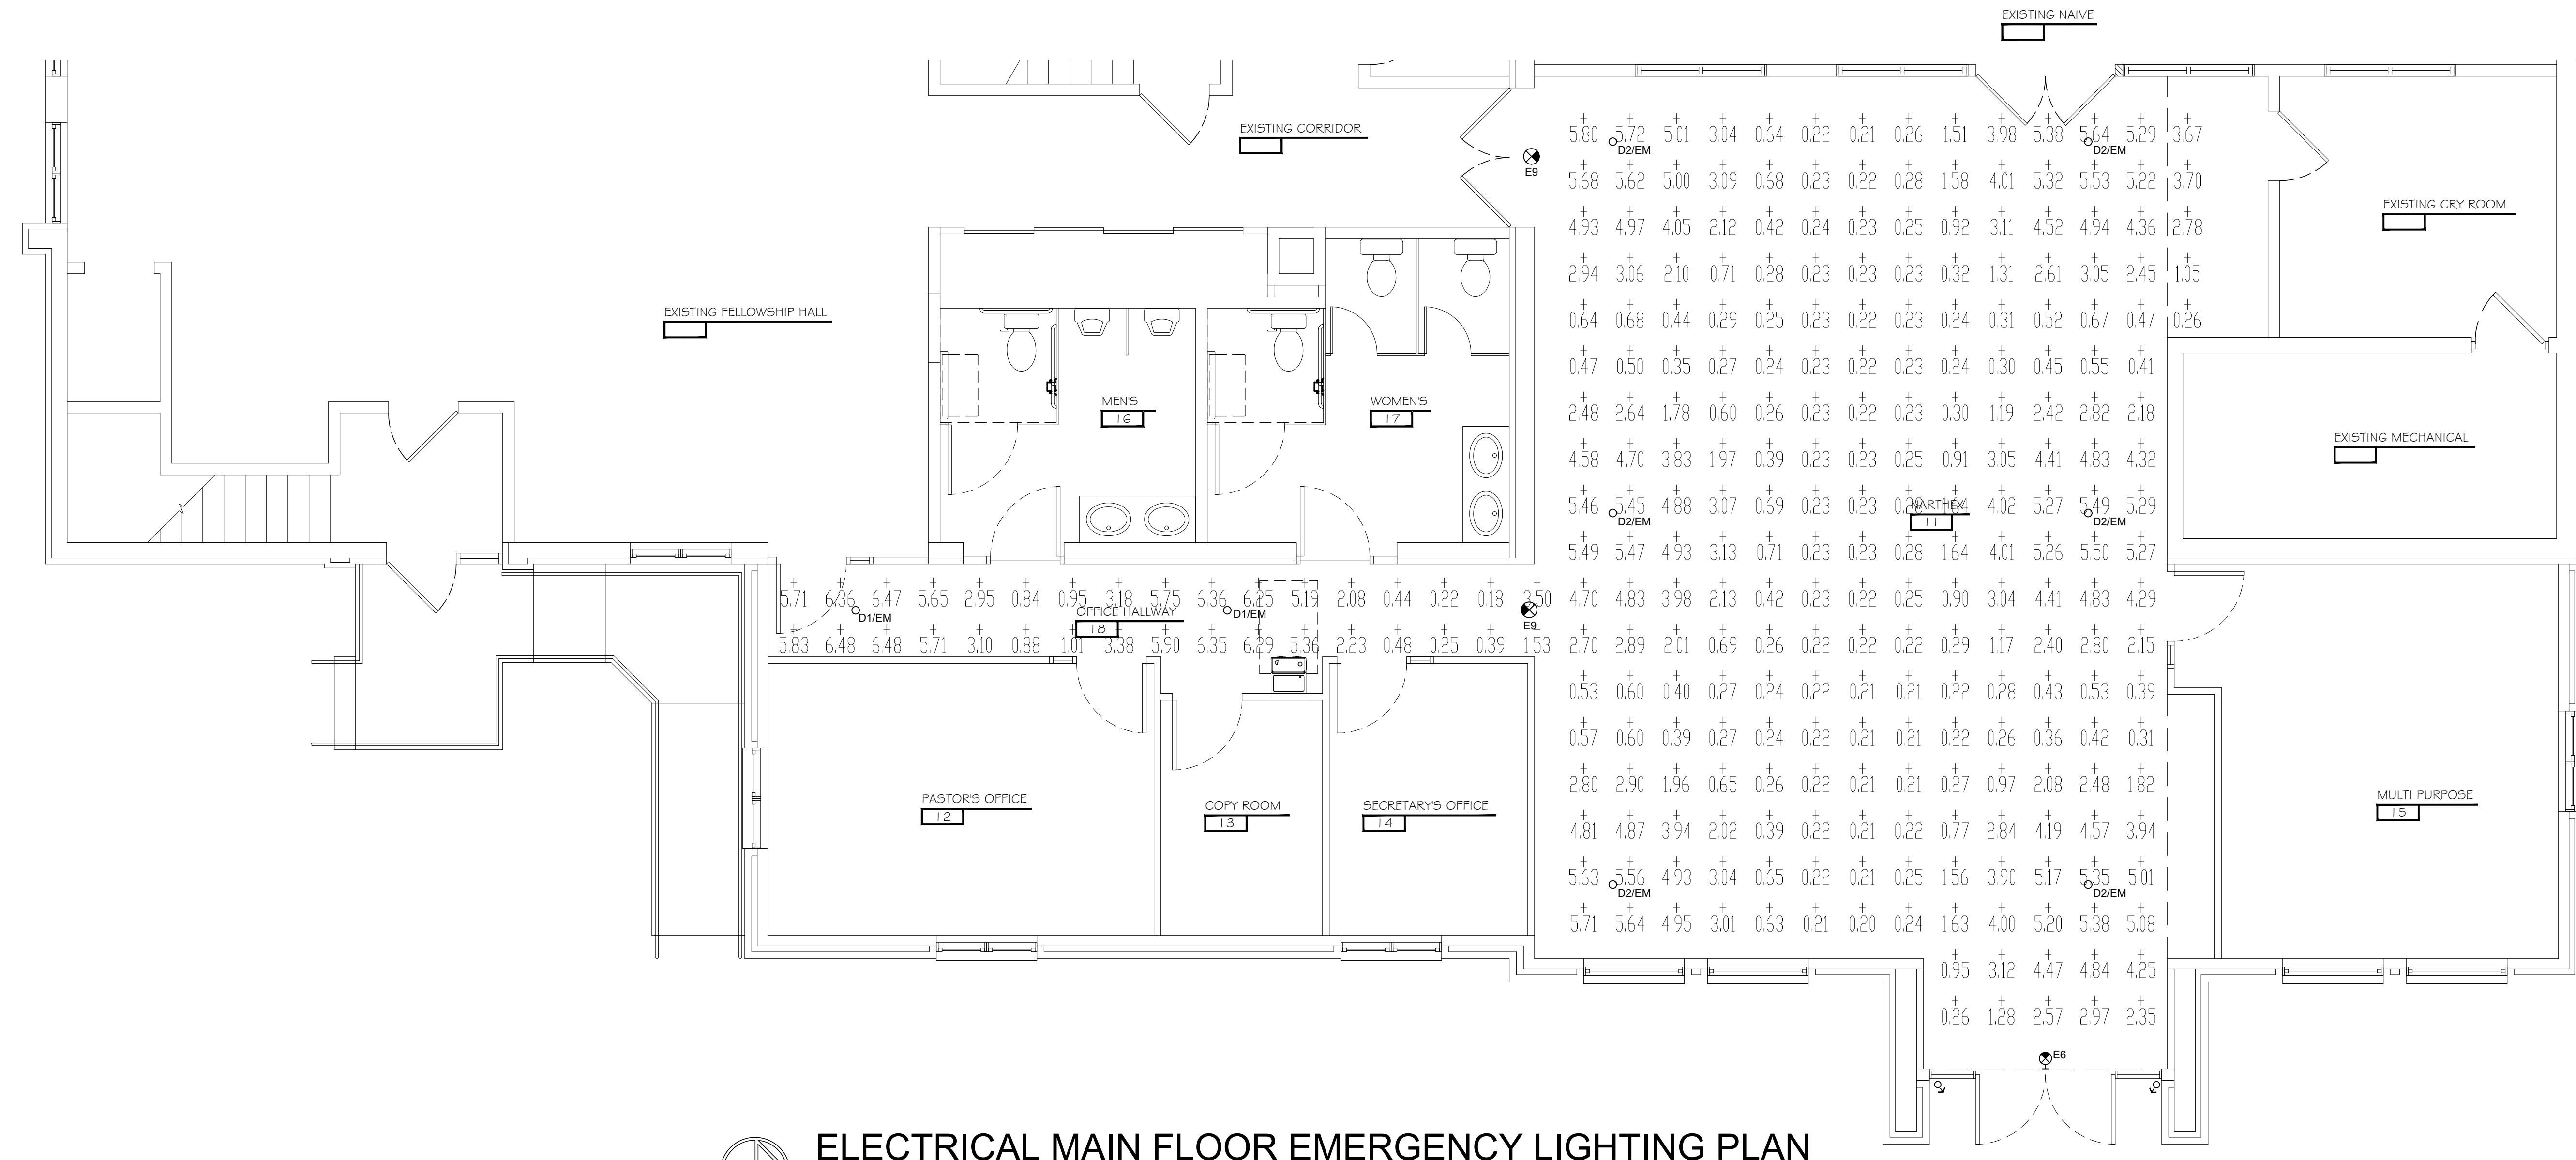

ELECTRICAL MAIN FLOOR EMERGENCY LIGHTING PLAN
 SCALE: 1/4" = 1'-0"

Verify all existing site conditions
 REVISIONS:

| SHEET INDEX: | |
|--------------|--|
| ELECTRICAL | |
| EMERGENCY | |
| LIGHTING | |
| PLAN | |

Copyright © 2017
 Ideo House, Inc.
 DRAWN: HLM
 APPRVD: HLM
 May 2, 2017

E201
 17-053 E200.DWG