


GENERAL ELECTRICAL CONSTRUCTION NOTES:

- 1 E.C. SHALL PERFORM A THOROUGH WALK THROUGH OF EXISTING FACILITY PRIOR TO SUBMITTING ELECTRICAL BID PRICES. E.C. SHALL REVIEW ALL BIDDING/CONSTRUCTION DOCUMENTS AND MUST HAVE A COMPLETE UNDERSTANDING OF PROJECT SCOPE.
- 2 E.C. SHALL COORDINATE ALL ELECTRICAL DEMOLITION WORK WITH OWNER AND ALL OTHER TRADES. E.C. SHALL BE RESPONSIBLE FOR THE PROPER DISCONNECTION AND REMOVAL OF ALL ELECTRICAL DEVICES NEEDED TO BE REMOVED, RELOCATED TO ACCOMMODATE ALL BUILDING DEMOLITION, CONSTRUCTION.
- 3 ALL ELECTRICAL INSTALLATIONS SHALL BE PERFORMED IN COMPLETE COMPLIANCE WITH ALL PERTINENT NATIONAL, STATE, AND LOCAL CODES AND REGULATIONS.
- 4 SHOULD THE ELECTRICAL CONTRACTOR IN REVIEWING THE ELECTRICAL PLANS AND SPECIFICATIONS RECOGNIZE ANY POINTS WHICH TO THEM SEEM TO BE INSUFFICIENTLY OR IMPROPERLY CARED FOR, OR ANY NECESSARY ITEMS OR EQUIPMENT OMITTED TO THE EXTENT OF JEOPARDIZING THE SYSTEMS' INTEGRITY, OR THE GUARANTEE, WHICH THE ELECTRICAL CONTRACTOR SHALL PROVIDE, IT IS THE RESPONSIBILITY OF THE ELECTRICAL CONTRACTOR TO STATE SUCH CONDITIONS TO THE ELECTRICAL DESIGNER IN WRITING, DURING THE BID PROCESS, SO SUCH ITEMS CAN BE ADDRESSED DURING THE BID PROCESS. IF THIS CONDITION IS NOT COMPLIED WITH, IT WILL BE ASSUMED THAT THE ELECTRICAL SYSTEMS COVERED IN THESE DOCUMENTS ARE SATISFACTORY TO THE CONTRACTOR AND THEY SHALL BE HELD BOUND TO THEIR GUARANTEE.

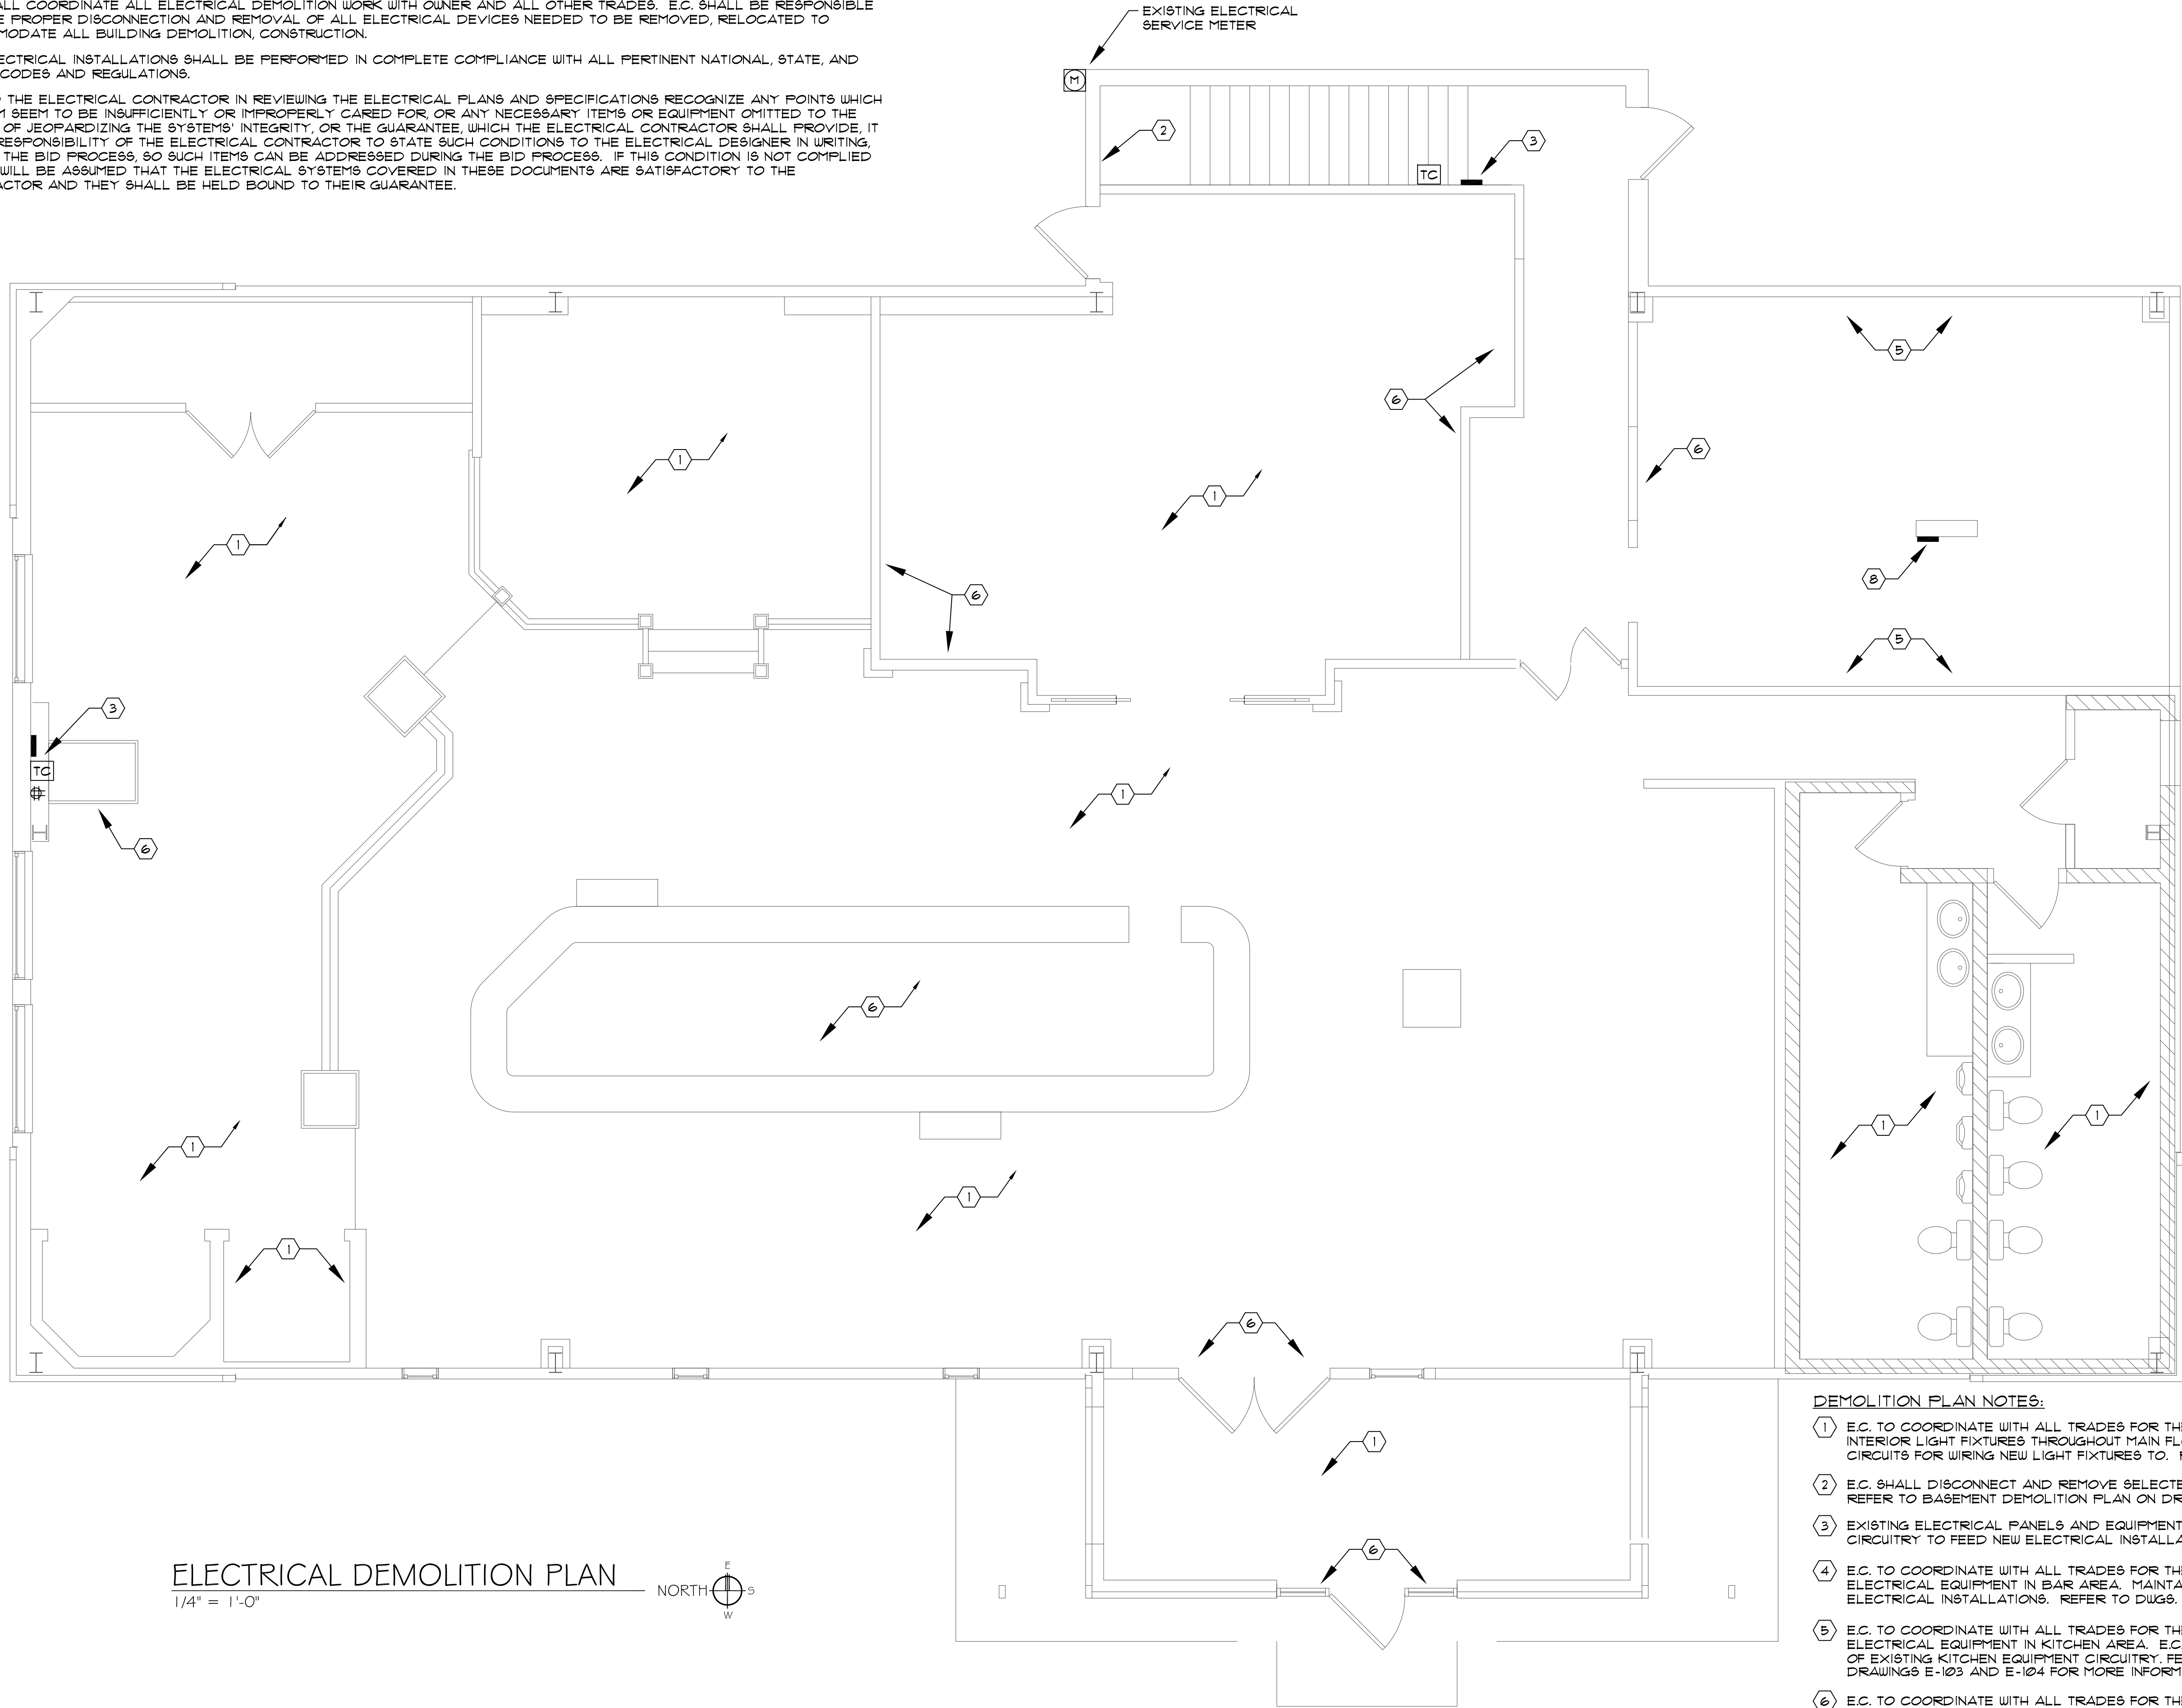

DEMOLITION PLAN NOTES:

- 1 E.C. TO COORDINATE WITH ALL TRADES FOR THE DISCONNECTION AND REMOVAL OF ALL EXISTING INTERIOR LIGHT FIXTURES THROUGHOUT MAIN FLOOR AREAS. E.C. TO MAINTAIN EXISTING LIGHTING CIRCUITS FOR WIRING NEW LIGHT FIXTURES TO. REFER TO DWG. E-102 FOR NEW LIGHTING LAYOUT.
- 2 E.C. SHALL DISCONNECT AND REMOVE SELECTED ELECTRICAL DISTRIBUTION AND VOICE/DATA EQUIPMENT. REFER TO BASEMENT DEMOLITION PLAN ON DRAWING E-104 FOR MORE INFORMATION.
- 3 EXISTING ELECTRICAL PANELS AND EQUIPMENT TO REMAIN IN SERVICE. E.C. SHALL REUSE EXISTING CIRCUITRY TO FEED NEW ELECTRICAL INSTALLATIONS.
- 4 E.C. TO COORDINATE WITH ALL TRADES FOR THE DISCONNECTION AND REMOVAL OF ALL EXISTING ELECTRICAL EQUIPMENT IN BAR AREA. MAINTAIN, REUSE EXISTING CIRCUITRY TO FEED NEW ELECTRICAL INSTALLATIONS. REFER TO DWGS. E-102 & E-103 FOR NEW LAYOUT.
- 5 E.C. TO COORDINATE WITH ALL TRADES FOR THE DISCONNECTION AND REMOVAL OF ALL EXISTING ELECTRICAL EQUIPMENT IN KITCHEN AREA. E.C. SHALL REMOVE EXISTING CONDUCTORS AND RACEWAY OF EXISTING KITCHEN EQUIPMENT CIRCUITRY. FEED NEW KITCHEN EQUIPMENT FROM NEW PANEL 'K'. REFER DRAWINGS E-103 AND E-104 FOR MORE INFORMATION.
- 6 E.C. TO COORDINATE WITH ALL TRADES FOR THE DISCONNECTION AND REMOVAL OF ALL EXISTING ELECTRICAL DEVICES, EQUIPMENT IN WALLS BEING REMOVED. MAINTAIN, REUSE EXISTING CIRCUITRY TO FEED NEW ELECTRICAL INSTALLATIONS. REFER TO DWGS. E-102 & E-103 FOR NEW LAYOUT.
- 7 E.C. SHALL DISCONNECT AND REMOVE BUILDINGS EXISTING SECURITY SYSTEM. E.C. TO INSTALL A NEW SECURITY SYSTEM IN BUILDING. REFER TO DWG. E-103 FOR MORE INFORMATION.
- 8 E.C. SHALL DISCONNECT AND REMOVE EXISTING KITCHEN POWER PANEL. E.C. TO INSTALL NEW PANEL 'K' IN NEW HALLWAY. REFER TO DWG. E-103 FOR MORE INFORMATION.

ELECTRICAL DEMOLITION PLAN

1/4" = 1'-0"

